



Received
14.9.10

1:500 SITE PLAN AT A1


mcculloughmulvinarchitects
 1 setanta place, dublin 2, ireland
 t: +353 1 707 9555 www.mcculloughmulvin.com
 f: +353 1 707 1912 info@mcculloughmulvin.com

COPYRIGHT AND OWNERSHIP OF THIS DRAWING IS VESTED IN MCCULLOUGH MULVIN WHOSE PRIOR WRITTEN CONSENT IS REQUIRED FOR ITS USE. REPRODUCTION OR FOR PUBLICATION TO ANY THIRD PARTY ALL RIGHTS RESERVED BY THE LAW OF COPYRIGHT AND BY INTERNATIONAL COPYRIGHT CONVENTIONS ARE HEREBY RESERVED TO MCCULLOUGH MULVIN AND MAY BE PROTECTED BY COURT PROCEEDINGS FOR DAMAGES AND/OR INJUNCTIONS AND COSTS.
DO NOT SCALE THIS DRAWING
 ALL WRITTEN DIMENSIONS ARE IN MILLIMETRES
 ANY INCONSISTENCIES TO BE REPORTED TO THE ARCHITECT IMMEDIATELY
 © MCCULLOUGH MULVIN 1998


BASED ON ORDNANCE SURVEY OF IRELAND LICENCE NO KILKENNY CCMA 0812
 MAP REF 4766-9
 REFER TO DATUM SURVEY DRAWINGS FOR EXISTING LAYOUT
 FOR DRAINAGE LAYOUT REFER TO DCSC DRAWING NO M821/010, M821/011, M821/012

REV	DATE	BY	DESCRIPTION


DRAWN LMD	PROJECT BUTLER GALLERY	SCALE 1:500 GRA1 1:1000GRA3	DRAWING NUMBER	REVISION
CHECKED ROH	CLIENT KILKENNY ARTS	JOB NUMBER 201002	BG-P-001	B
DRAWING TITLE	Butler Gallery Proposed Site Plan			

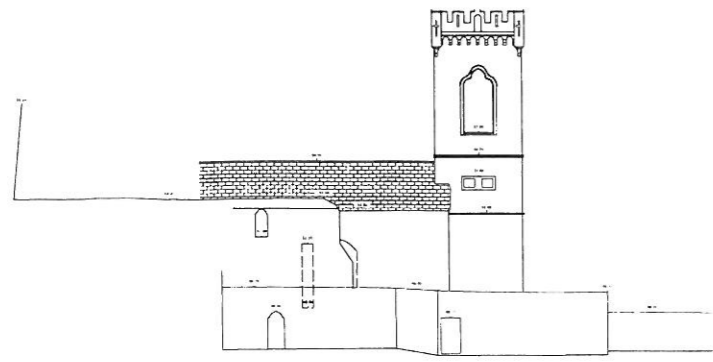

ST JOHN'S CHURCH
ELEVATION A1
NO ALTERATIONS

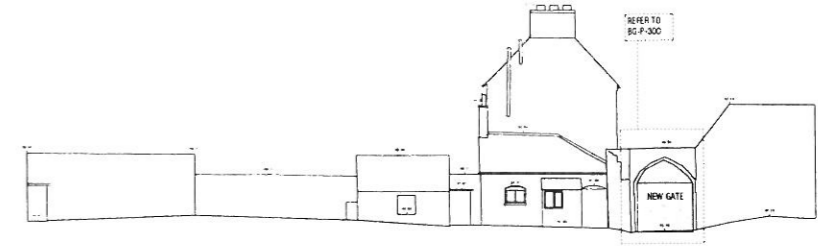


PROPOSED SOUTH EAST BOUNDARY WALL AND GATE HOUSE ELEVATION D1

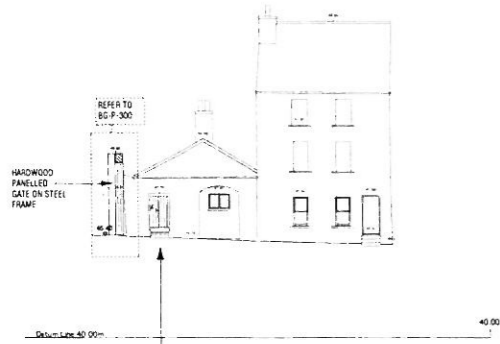


EXISTING ACCESS TO EVANS HOME SITE
NOT TO GATE HOUSE ITSELF

GATE HOUSE BARRACK LANE ELEVATION B1

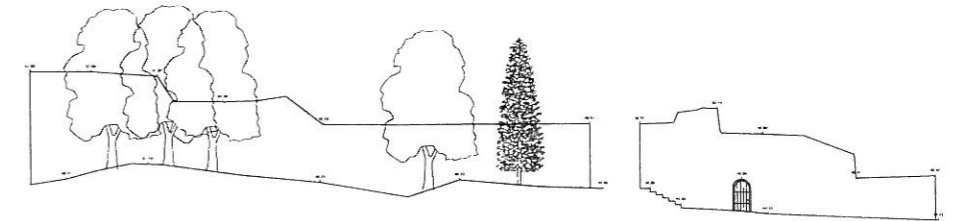


SOUTH WEST BOUNDARY WALL ELEVATION E1


CAR PARK ACCESS BOUNDARY WALL ELEVATION F1
NO ALTERATIONS

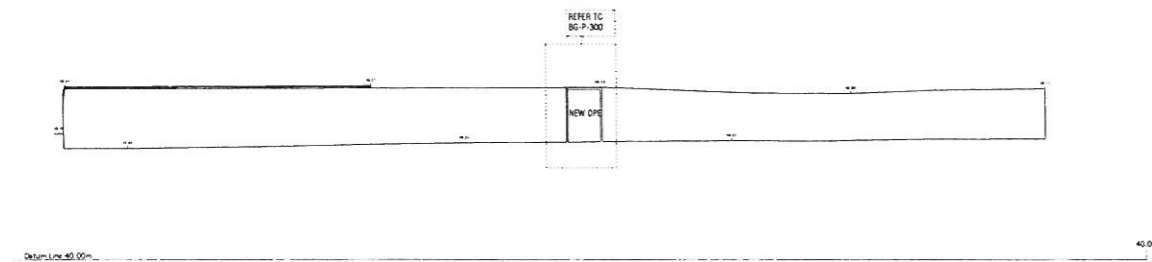


PROPOSED NORTH WEST BOUNDARY WALL ELEVATION C1

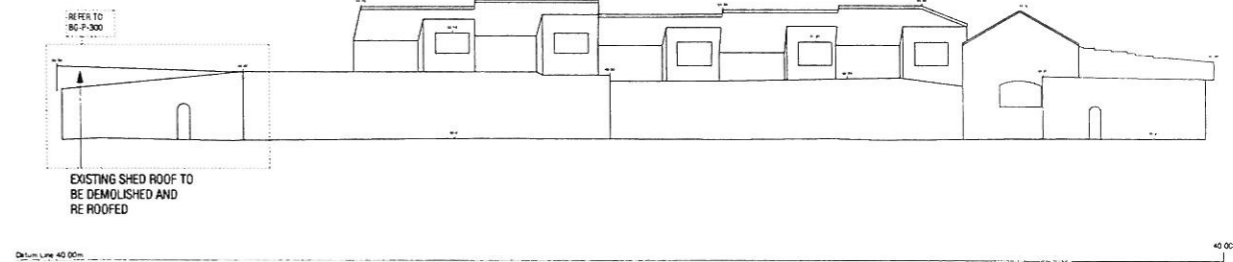

PROPOSED NORTH EAST BOUNDARY WALL ELEVATION G1

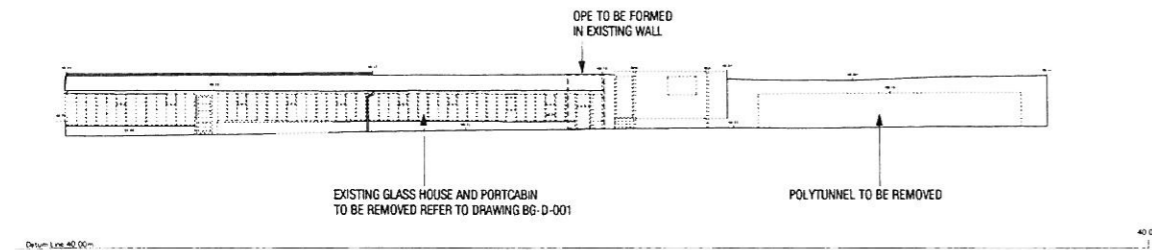

DEMOLITION NORTH WEST BOUNDARY WALL ELEVATION C1

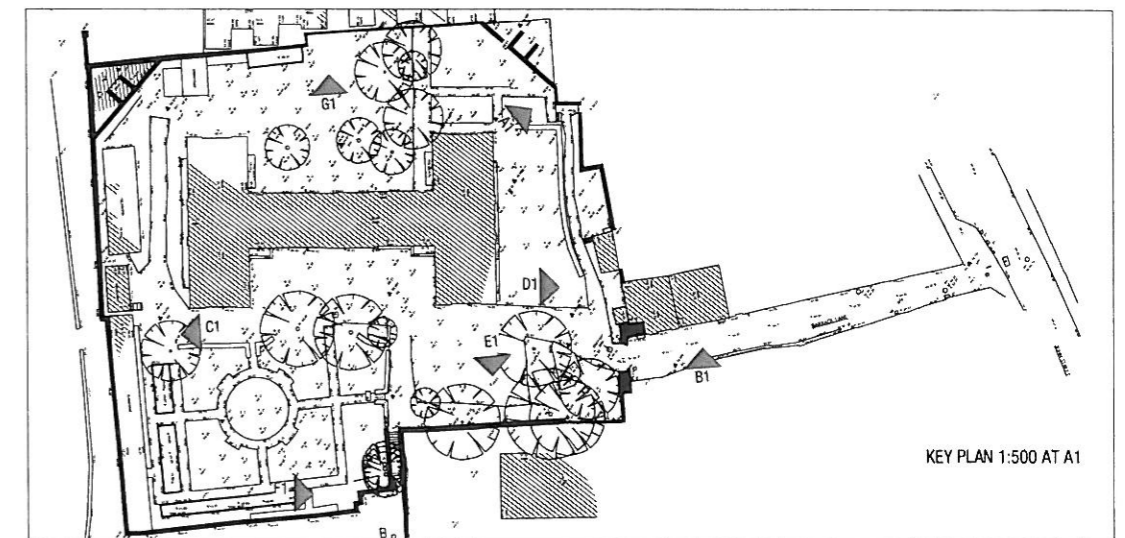

KEY PLAN 1:500 AT A1

mcculloughmulvinarchitects

1 setanta place, dublin 2, ireland
t: +353 1 707 9555 www.mcculloughmulvin.com
f: +353 1 707 1912 info@mcculloughmulvin.com

"COPYRIGHT AND OWNERSHIP OF THIS DRAWING IS VESTED IN MCCULLOUGH-MULVIN WHOSE PRIOR WRITTEN CONSENT IS REQUIRED FOR ITS USE, REPRODUCTION OR FOR PUBLICATION TO ANY THIRD PARTY. ALL RIGHTS RESERVED BY THE LAW OF COPYRIGHT AND BY INTERNATIONAL COPYRIGHT CONVENTIONS ARE RESERVED TO MCCULLOUGH-MULVIN AND MAY BE PROTECTED BY COURT PROCEEDINGS FOR DAMAGES AND/OR INJUNCTIONS AND COSTS."
DO NOT SCALE THIS DRAWING. ALL WRITTEN DIMENSIONS ARE IN MILLIMETRES. ANY INCONSISTENCIES TO BE REPORTED TO THE ARCHITECT IMMEDIATELY.
© MCCULLOUGH-MULVIN 1999

LEGEND

In the ownership of Evans Home Trust
(not part of application)

Demolition
Form Ope

REV DATE BY DESCRIPTION

DRAWN LMD	PROJECT BUTLER GALLERY	SCALE 1:200 @A1 1:400@A3	DRAWING NUMBER
CHECKED FOM	CLIENT KILKENNY ARTS	JOB NUMBER 201002	
DRAWING TITLE			
Perimeter Wall Conservation /Restoration			

BG-P-010


REVISION



mcculloughmulvinarchitects
 1 wexham place, dublin 2, ireland
 t +353 1 707 9555 www.mcculloughmulvin.com
 f +353 1 707 1912 info@mcculloughmulvin.com

"COPYRIGHT AND OWNERSHIP" OF THIS DRAWING IS VESTED IN MCCULLOUGH MULVIN WHOSE PRIOR WRITTEN CONSENT IS REQUIRED FOR ITS USE. REPRODUCTION OR FOR PUBLICATION TO ANY THIRD PARTY. ALL RIGHTS RESERVED BY THE LAW OF COPYRIGHT AND BY INTERNATIONAL COPYRIGHT CONVENTIONS ARE RESERVED TO MCCULLOUGH MULVIN AND MAY BE PROTECTED BY COURT PROCEEDINGS FOR DAMAGES AND/OR INJUNCTIONS AND COSTS.
 DO NOT SCALE THIS DRAWING. ALL WRITTEN DIMENSIONS ARE IN MILLIMETRES. ANY INCONSISTENCIES TO BE REPORTED TO THE ARCHITECT IMMEDIATELY.


REFER TO DATUM SURVEY DRAWINGS FOR EXISTING LAYOUT
 REFER TO BG-D-100 DRAWING SERIES FOR WORKS TO EXISTING BUILDING
 FOR LOCATION OF SITE NOTICES REFER TO BG-P-001

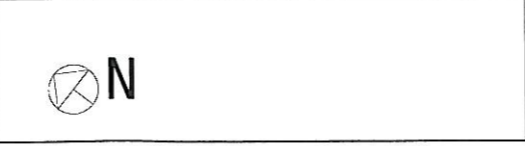

REV	DATE	BY	DESCRIPTION
B	290610	JM	WC's removed, Revisions to doors and walls shown butbled
C	300610	LMD	Location of existing trees updated
D	160710	roc	General drawing update
E	220710	roc	landscaping updated
F	270710	LMD	GENERAL UPDATE
G	050810	LMD	GENERAL DRAWING UPDATE
H	120810	LMD	GENERAL DRAWING UPDATE

DRAWN LMD	PROJECT BUTLER GALLERY	SCALE 1:200 @A1 1:400@A3	DRAWING NUMBER
CHECKED ROH	CLIENT KILKENNY ARTS	JOB NUMBER 201002	BG-P-100
DRAWING TITLE PROPOSED GROUND FLOOR PLAN			

REVISION J

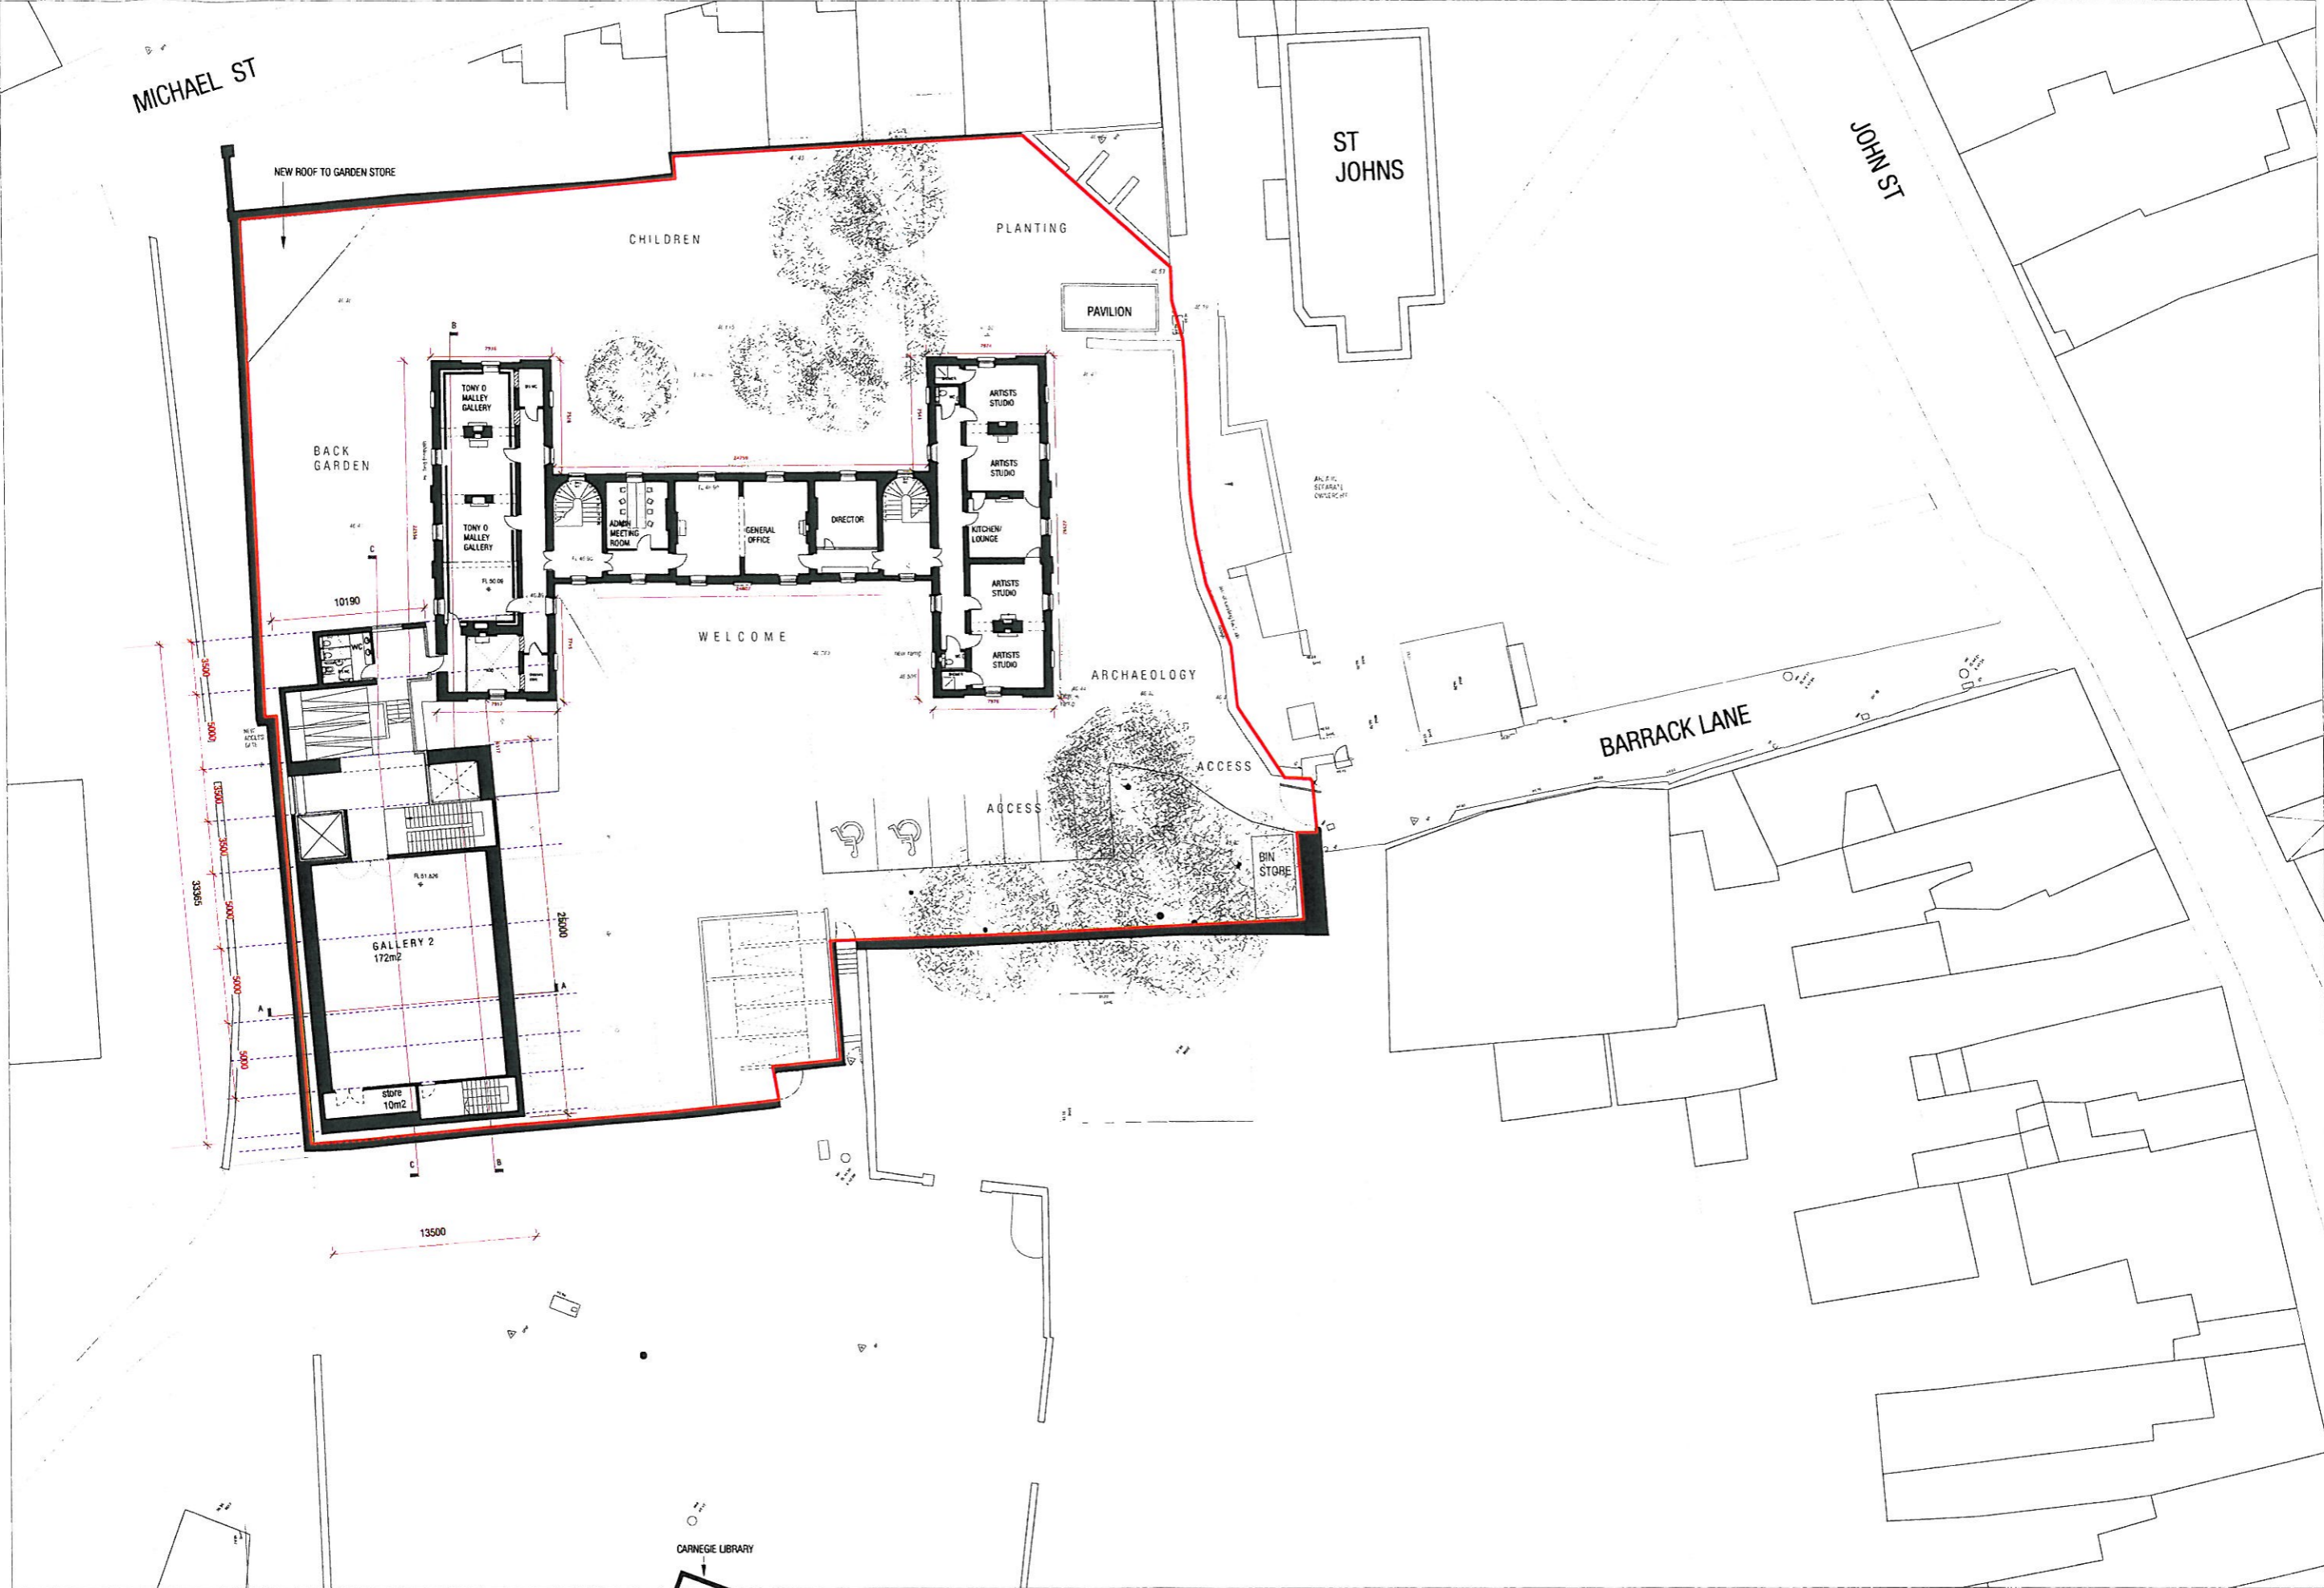

mcculloughmulvinarchitects

1 aaranta place, dublin 2, ireland
 t: +353 1 707 8666 www.mcculloughmulvin.com
 f: +353 1 707 1818 info@mcculloughmulvin.com

"COPYRIGHT AND OWNERSHIP OF THIS DRAWING IS VESTED IN MCCULLOUGH MULVIN WHOSE PRIOR WRITTEN CONSENT IS REQUIRED FOR ITS USE, REPRODUCTION OR FOR PUBLICATION TO ANY THIRD PARTY. ALL RIGHTS RESERVED BY THE LAW OF COPYRIGHT AND BY INTERNATIONAL COPYRIGHT CONVENTIONS ARE RESERVED TO MCCULLOUGH MULVIN AND MAY BE PROTECTED BY COURT PROCEEDINGS FOR DAMAGES AND/OR INJUNCTIONS AND COSTS."
 DO NOT SCALE THIS DRAWING.
 ALL WRITTEN DIMENSIONS ARE IN MILLIMETRES.
 ANY INCONSISTENCIES TO BE REPORTED TO THE ARCHITECT IMMEDIATELY.

REFER TO DATUM SURVEY DRAWINGS FOR EXISTING LAYOUT
 REFER TO BG-D-100 DRAWING SERIES FOR WORKS TO EXISTING BUILDING
 FOR LOCATION OF SITE NOTICES REFER TO BG-P-001



REV	DATE	BY	DESCRIPTION
B	290610	JM	Revisions to doors and walls shown bubbled
C	300610	LMD	Location of existing trees updated
D	160710	roc	General drawing update
E	220710	roc	landscaping updated
F	270710	LMD	GENERAL UPDATE
G	050810	LMD	GENERAL DRAWING UPDATE
H	120810	LMD	GENERAL DRAWING UPDATE


DRAWN LMD	PROJECT BUTLER GALLERY	SCALE 1:200 (A1)	DRAWING NUMBER
CHECKED RCH	CLIENT KILKENNY ARTS	JOB NUMBER 201002	BG-P-101
DRAWING TITLE	PROPOSED FIRST FLOOR PLAN		

REVISION
J

MICHAEL ST

ST JOHNS

JOHN ST

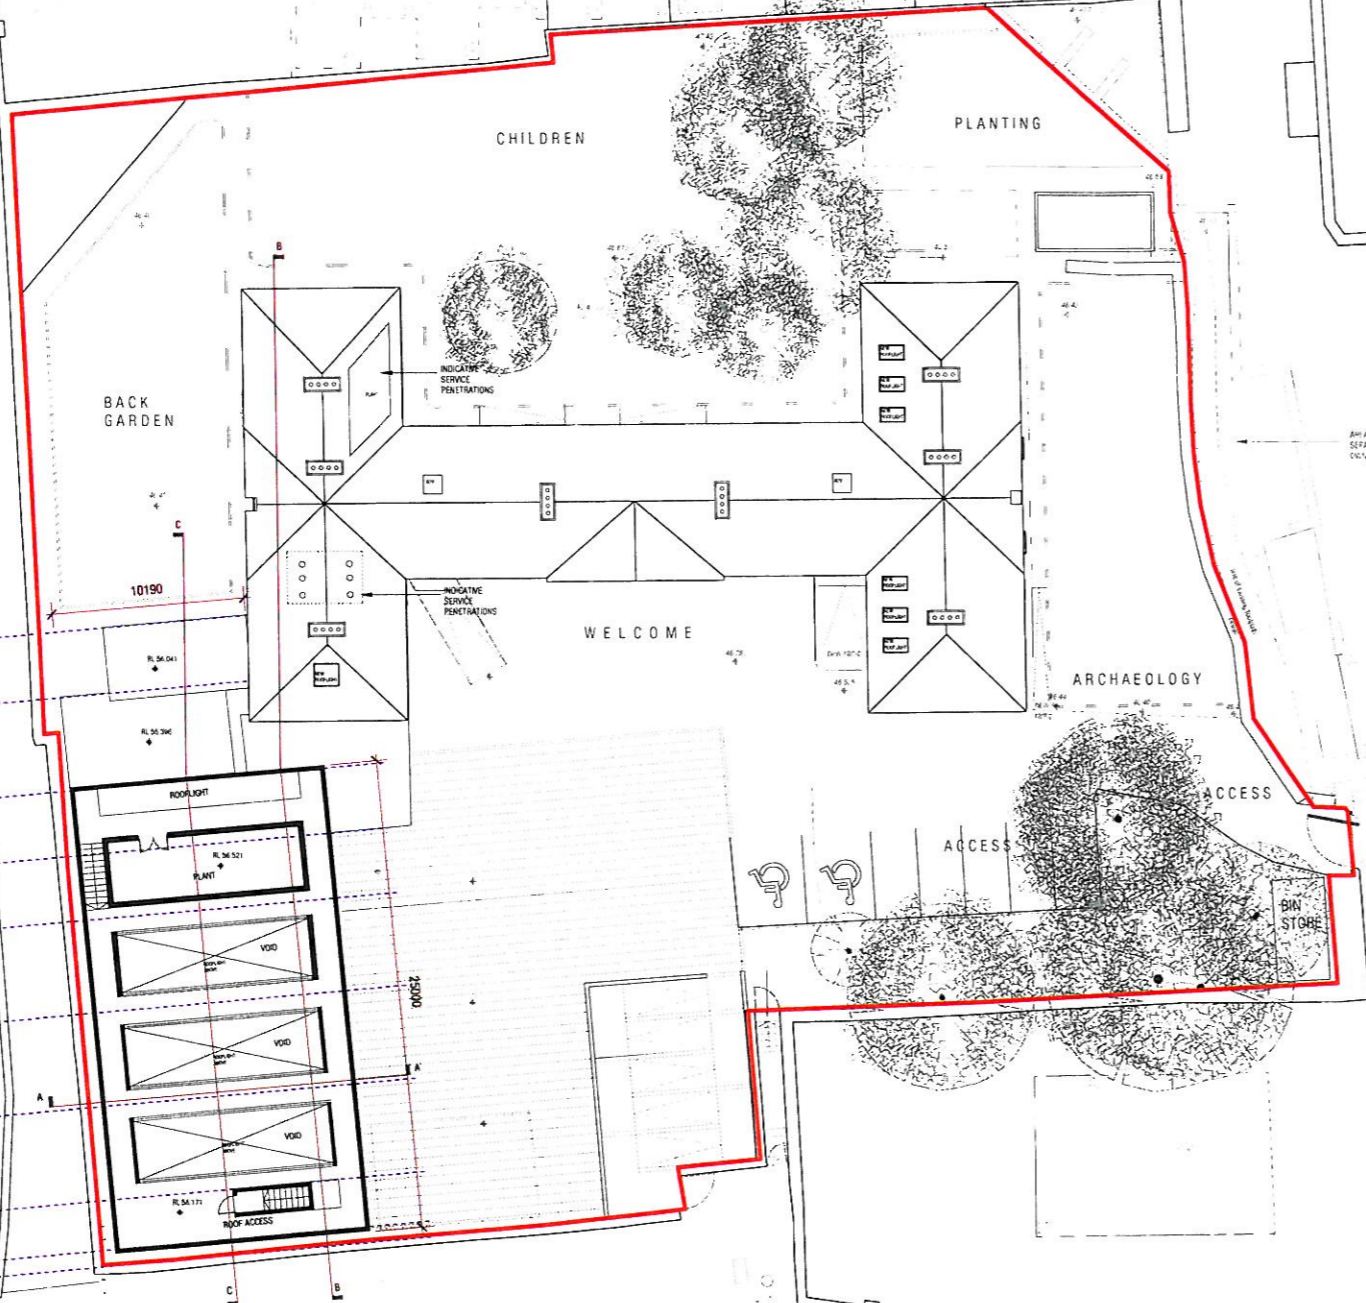

BARRACK LANE

CARNEGIE LIBRARY

mcculloughmulvinarchitects

1 astanta place, dublin 2, ireland
t: +353 1 707 9555
f: +353 1 707 1812
www.mcculloughmulvin.com
info@mcculloughmulvin.com

"COPYRIGHT AND OWNERSHIP OF THIS DRAWING IS VESTED IN MCCULLOUGH MULVIN WHOSE PRIOR WRITTEN CONSENT IS REQUIRED FOR ITS USE, REPRODUCTION OR FOR PUBLICATION TO ANY THIRD PARTY
ALL RIGHTS RESERVED BY THE LAW OF COPYRIGHT AND BY INTERNATIONAL COPYRIGHT CONVENTIONS ARE RESERVED TO MCCULLOUGH MULVIN AND MAY BE PROTECTED BY COURT PROCEEDINGS FOR DAMAGES AND/OR INJUNCTIONS AND COSTS."
DO NOT SCALE THIS DRAWING
ALL WRITTEN DIMENSIONS ARE IN MILLIMETRES
ANY INCONSISTENCIES TO BE REPORTED TO THE ARCHITECT IMMEDIATELY
© MCCULLOUGH MULVIN 1998

REFER TO DATUM SURVEY DRAWINGS FOR EXISTING LAYOUT
FOR LOCATION OF SITE NOTICES REFER TO BG-P-001



REV	DATE	BY	DESCRIPTION
C	27/07/10	LMD	GENERAL UPDATE
D	05/08/10	LMD	GENERAL DRAWING UPDATE
E	12/08/10	LMD	GENERAL DRAWING UPDATE

DRAWN LMD	PROJECT BUTLER GALLERY	SCALE 1:200 @A1 1:400 @A3	DRAWING NUMBER
CHECKED ROH	CLIENT KILKENNY ARTS	JOB NUMBER 201002	
DRAWING TITLE PROPOSED LOWER ROOF PLAN			

BG-P-102


REVISION
G



mcculloughmulvinarchitects
 1 setanta place, dublin 2, ireland
 t +353 1 707 9555
 f +353 1 707 1812
 www.mcculloughmulvin.com
 info@mcculloughmulvin.com


"COPYRIGHT AND OWNERSHIP OF THIS DRAWING IS VESTED IN MCCULLOUGH MULVIN WHOSE PRIOR WRITTEN CONSENT IS REQUIRED FOR ITS USE. REPRODUCTION OR FOR PUBLICATION TO ANY THIRD PARTY.
 ALL RIGHTS RESERVED BY THE LAW OF COPYRIGHT AND BY INTERNATIONAL COPYRIGHT CONVENTIONS ARE RESERVED TO MCCULLOUGH MULVIN AND MAY BE PROTECTED BY COURT PROCEEDINGS FOR DAMAGES AND/OR INJUNCTIONS AND COSTS."
 DO NOT SCALE THIS DRAWING.
 ALL WRITTEN DIMENSIONS ARE IN MILLIMETRES.
 ANY INCONSISTENCIES TO BE REPORTED TO THE ARCHITECT IMMEDIATELY.
 © MCCULLOUGH MULVIN 1998

REFER TO DATUM SURVEY DRAWINGS FOR EXISTING LAYOUT
 FOR LOCATION OF SITE NOTICES REFER TO BG-P-001

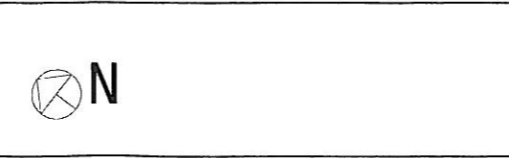


REV	DATE	BY	DESCRIPTION
C	270710	LMD	GENERAL UPDATE
D	050810	LMD	GENERAL DRAWING UPDATE
E	120810	LMD	GENERAL DRAWING UPDATE


DRAWN LMD	PROJECT BUTLER GALLERY	SCALE 1:200 GA1 1:400 GA3	DRAWING NUMBER
CHECKED RHM	CLIENT KILKENNY ARTS	JOB NUMBER 201002	BG-P-103
DRAWING TITLE PROPOSED ROOF PLAN			G

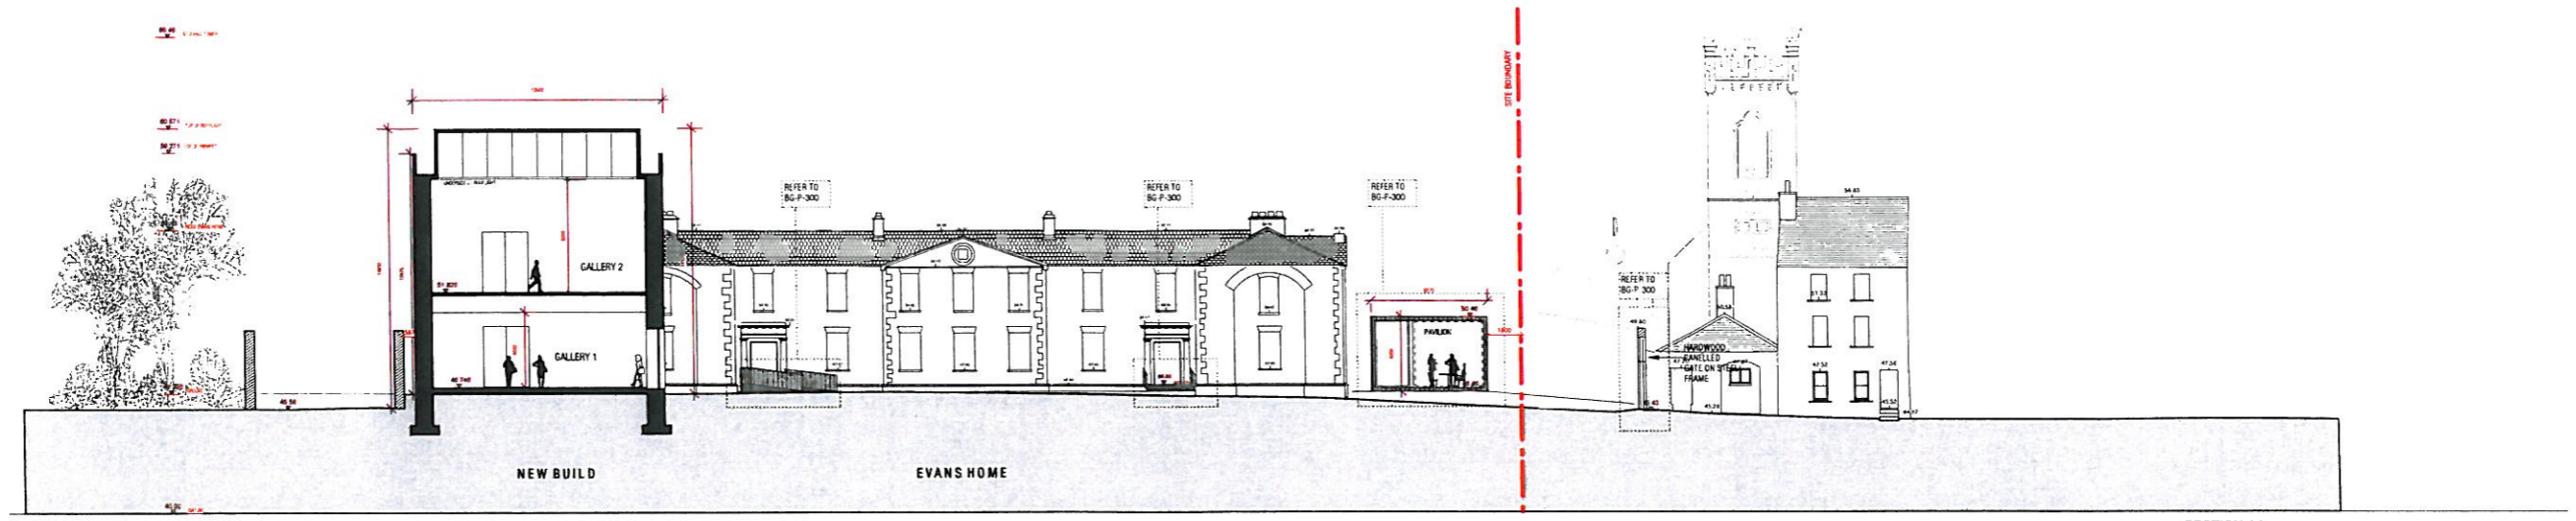

SECTION AA

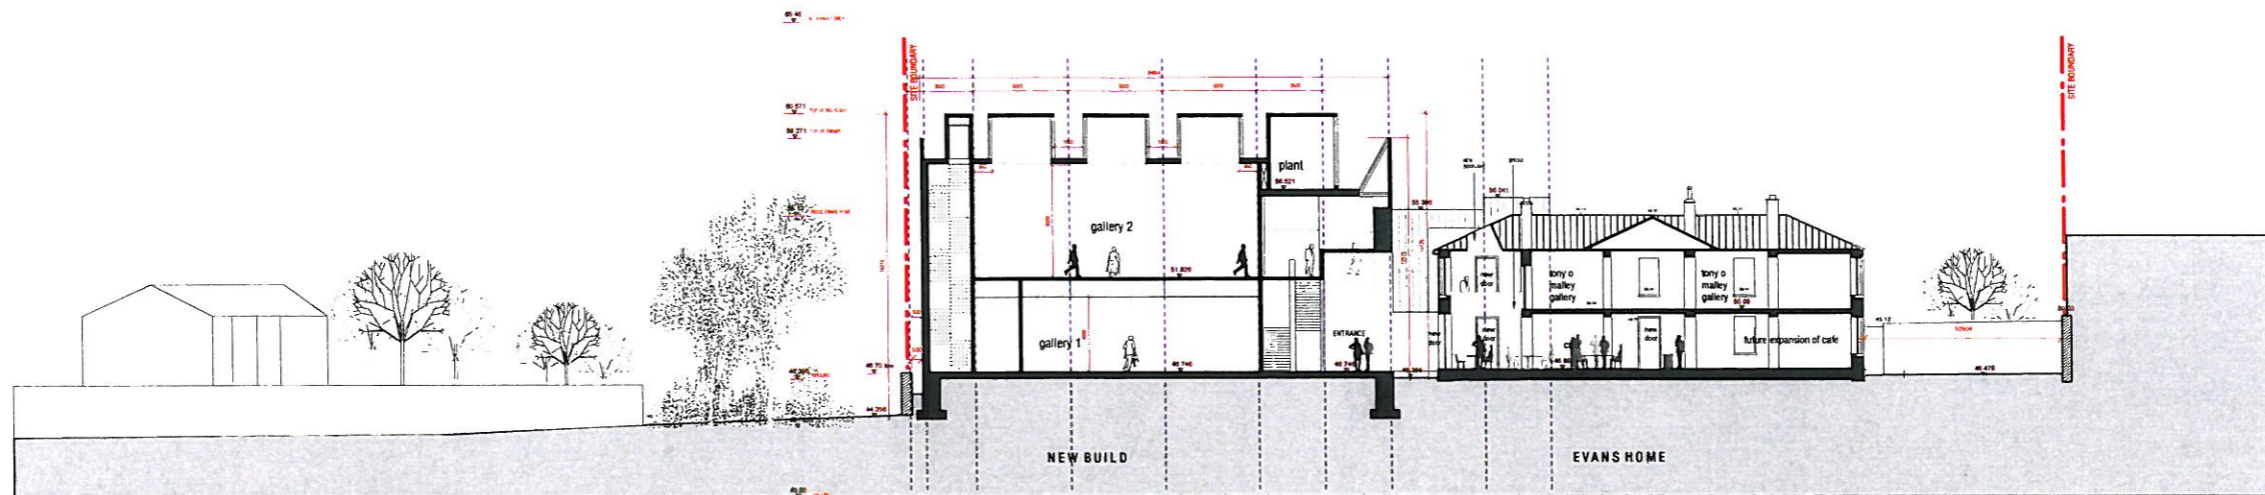

SECTION BB

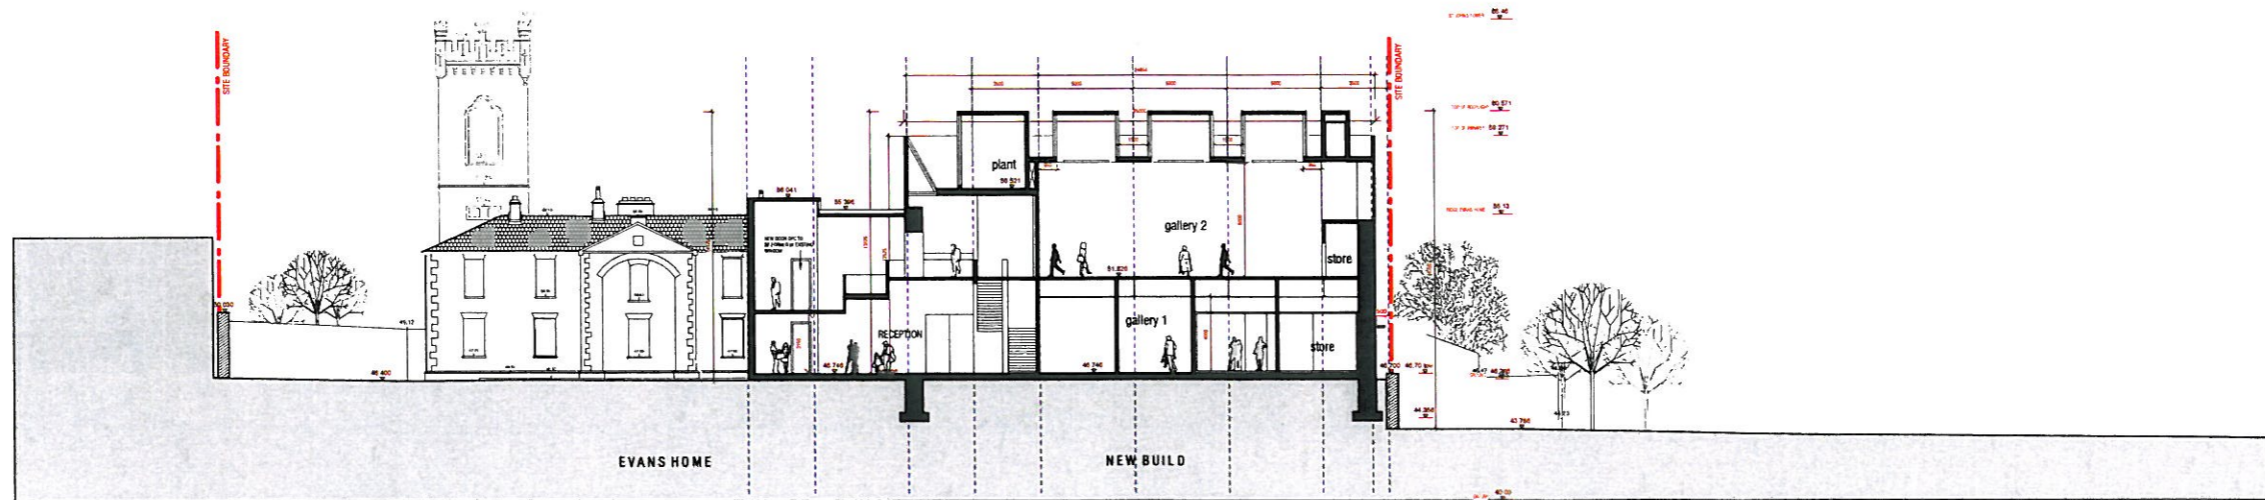

SECTION CC

mcculloughmulvinarchitects

1 saranta place, dublin 2, Ireland

T: +353 1 707 8555
F: +353 1 707 1812

www.mcculloughmulvin.com
info@mcculloughmulvin.com

*COPYRIGHT AND OWNERSHIP OF THIS DRAWING IS VESTED IN MCCULLOUGH MULVIN WHOSE PRIOR WRITTEN CONSENT IS REQUIRED FOR ITS USE, REPRODUCTION OR FOR PUBLICATION TO ANY THIRD PARTY. ALL RIGHTS RESERVED BY THE LAW OF COPYRIGHT AND BY INTERNATIONAL COPYRIGHT CONVENTIONS ARE RESERVED TO MCCULLOUGH MULVIN AND MAY BE PROTECTED BY COURT PROCEEDINGS FOR DAMAGES AND/OR INJUNCTIONS AND COSTS.

DO NOT SCALE THIS DRAWING. ALL WRITTEN DIMENSIONS ARE IN MILLIMETRES. ANY INCONSISTENCIES TO BE REPORTED TO THE ARCHITECT IMMEDIATELY.


© MCCULLOUGH MULVIN 1998

REV	DATE	BY	DESCRIPTION
0	05/08/10	LMD	GENERAL DRAWING UPDATE


DRAWN	PROJECT	SCALE
LMD	BUTLER GALLERY	1:200 @A1 1:400 @A3
CHECKED	CLIENT	JOB NUMBER
ROH	KILKENNY ARTS	201002
DRAWING	TITLE	
	NEW BUILD PROPOSED SECTIONS SECTION AA,BB,CC	

DRAWING	DRAWING
NUMBER	NUMBER
BG-P-150	

REVISION	
E	

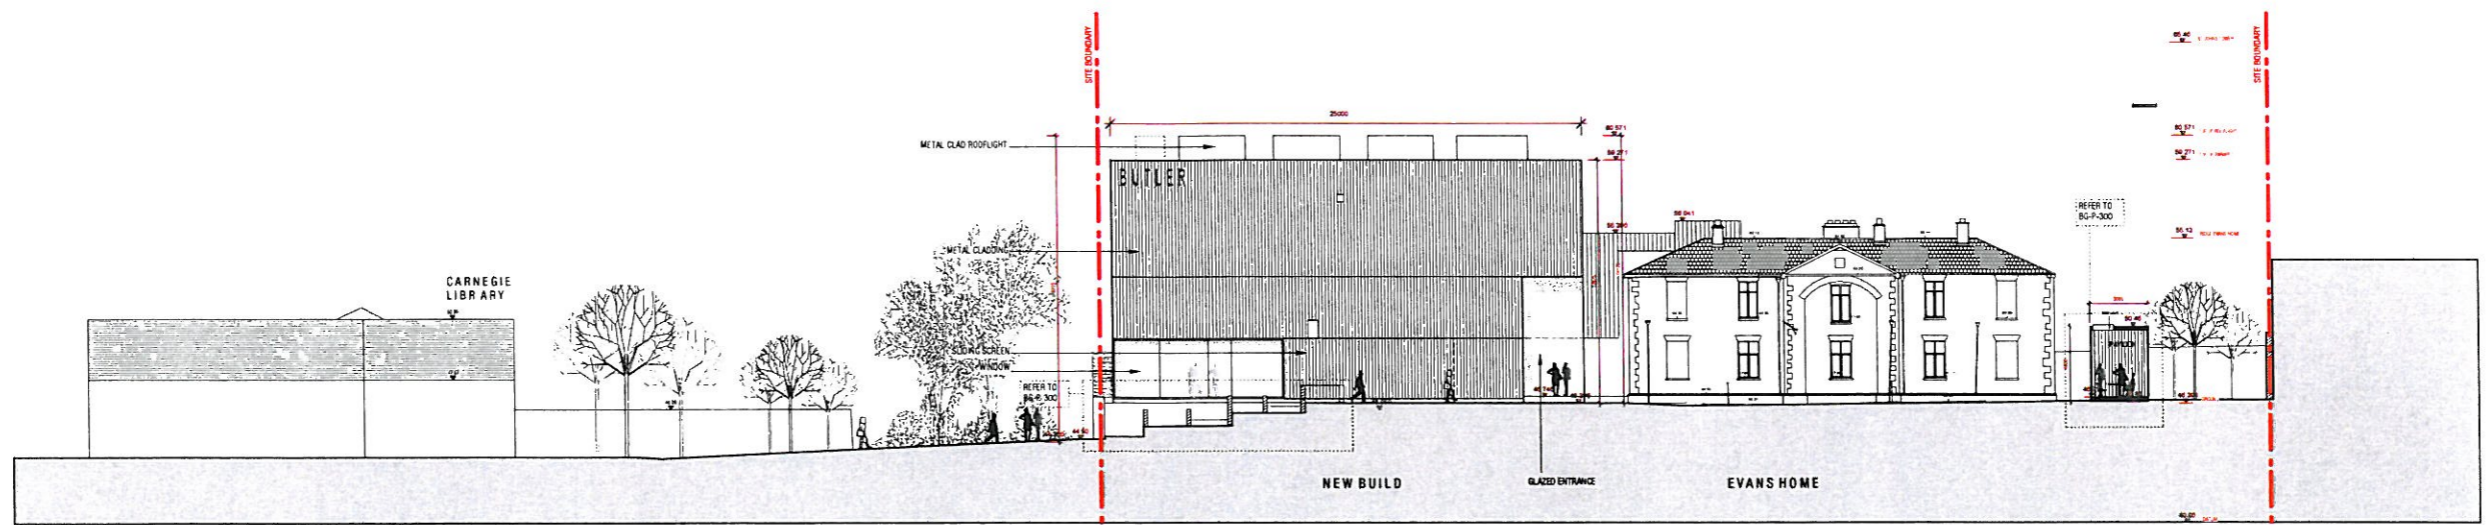


SOUTH EAST ELEVATION

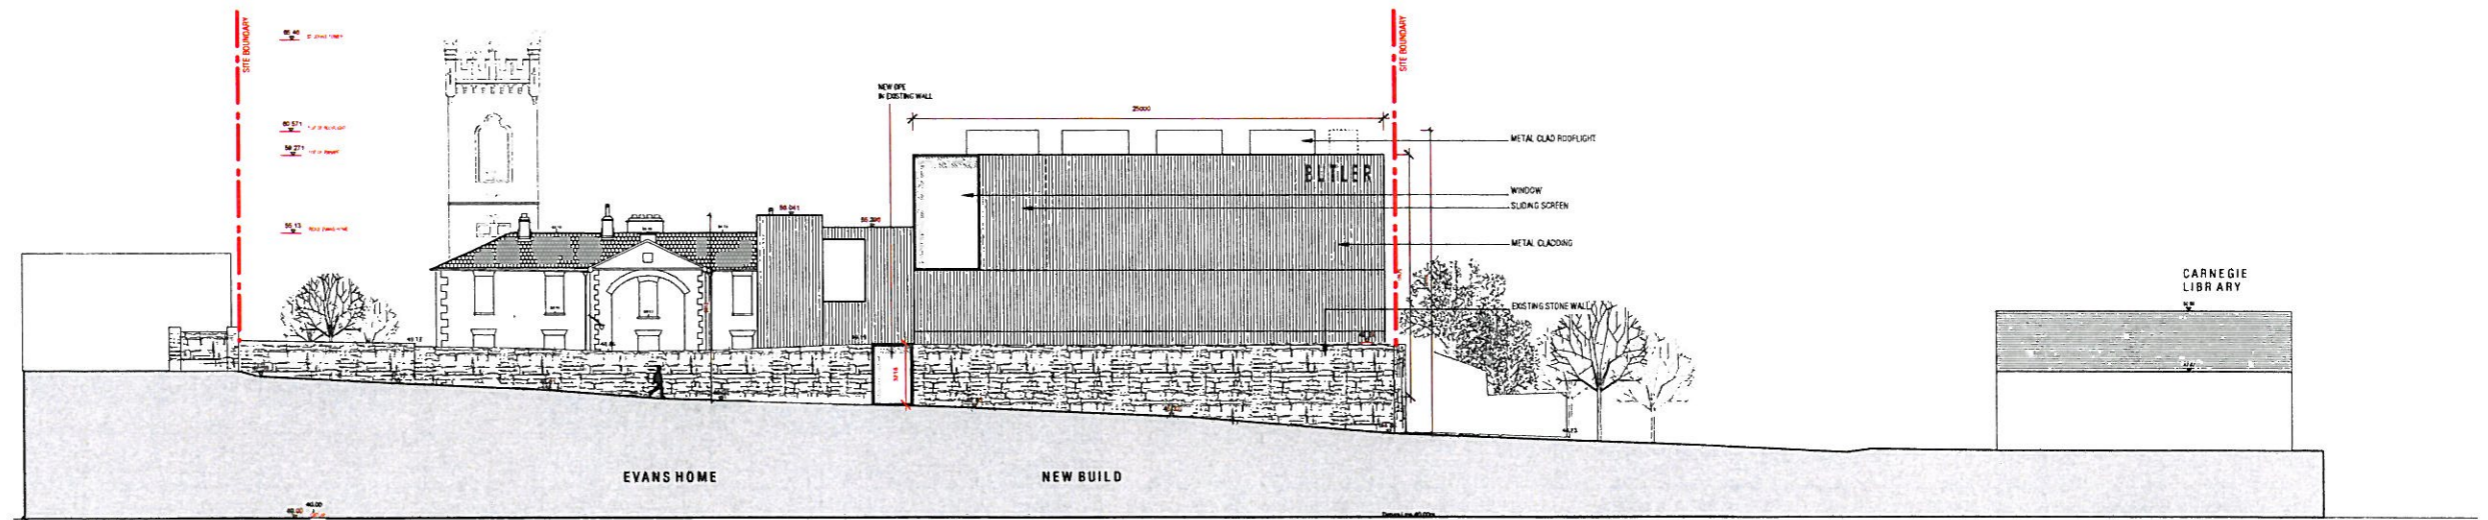


NORTH WEST ELEVATION

mcculloughmulvinarchitects 1 setanta place, dublin 2, ireland t: +353 1 707 8655 www.mcmulvin.com f: +353 1 707 1812 info@mcmulvin.com	<small> *COPYRIGHT AND OWNERSHIP OF THIS DRAWING IS VESTED IN MCCULLOUGH MULVIN WHOSE PRIOR WRITTEN CONSENT IS REQUIRED FOR ITS USE, REPRODUCTION OR FOR PUBLICATION TO ANY THIRD PARTY. ALL RIGHTS RESERVED BY THE LAW OF COPYRIGHT AND BY INTERNATIONAL COPYRIGHT CONVENTIONS ARE RESERVED TO MCCULLOUGH MULVIN AND MAY BE PROTECTED BY COURT PROCEEDINGS FOR DAMAGES AND/OR INJUNCTIONS AND COSTS. DO NOT SCALE THIS DRAWING. ALL WRITTEN DIMENSIONS ARE IN MILLIMETRES. ANY INCONSISTENCIES TO BE REPORTED TO THE ARCHITECT IMMEDIATELY. © MCCULLOUGH MULVIN 1998 </small>	<table border="1"> <tr> <th>REV</th> <th>DATE</th> <th>BY</th> <th>DESCRIPTION</th> </tr> <tr> <td>B</td> <td>180710</td> <td>RM</td> <td>General drawing update</td> </tr> <tr> <td>D</td> <td>050810</td> <td>LMD</td> <td>GENERAL UPDATE</td> </tr> <tr> <td>E</td> <td>120810</td> <td>LMD</td> <td>GENERAL DRAWING UPDATE</td> </tr> </table>	REV	DATE	BY	DESCRIPTION	B	180710	RM	General drawing update	D	050810	LMD	GENERAL UPDATE	E	120810	LMD	GENERAL DRAWING UPDATE	<table border="1"> <tr> <td>DRAWN</td> <td>PROJECT</td> <td>SCALE</td> <td>DRAWING</td> </tr> <tr> <td>LMD</td> <td>BUTLER GALLERY</td> <td>1:200 GRA1</td> <td>NUMBER</td> </tr> <tr> <td></td> <td></td> <td>1:400GA3</td> <td></td> </tr> <tr> <td>CHECKED</td> <td>CLIENT</td> <td>JOB NUMBER</td> <td rowspan="2"> <h1>BG-P-160</h1> </td> </tr> <tr> <td>RM</td> <td>KILKENNY ARTS</td> <td>201002</td> </tr> <tr> <td colspan="4">DRAWING TITLE</td> </tr> <tr> <td colspan="4">Proposed New Build South East & North West Elevation</td> </tr> </table>	DRAWN	PROJECT	SCALE	DRAWING	LMD	BUTLER GALLERY	1:200 GRA1	NUMBER			1:400GA3		CHECKED	CLIENT	JOB NUMBER	<h1>BG-P-160</h1>	RM	KILKENNY ARTS	201002	DRAWING TITLE				Proposed New Build South East & North West Elevation				<table border="1"> <tr> <td>REVISION</td> </tr> <tr> <td>F</td> </tr> </table>	REVISION	F
			REV	DATE	BY	DESCRIPTION																																											
B	180710	RM	General drawing update																																														
D	050810	LMD	GENERAL UPDATE																																														
E	120810	LMD	GENERAL DRAWING UPDATE																																														
DRAWN	PROJECT	SCALE	DRAWING																																														
LMD	BUTLER GALLERY	1:200 GRA1	NUMBER																																														
		1:400GA3																																															
CHECKED	CLIENT	JOB NUMBER	<h1>BG-P-160</h1>																																														
RM	KILKENNY ARTS	201002																																															
DRAWING TITLE																																																	
Proposed New Build South East & North West Elevation																																																	
REVISION																																																	
F																																																	

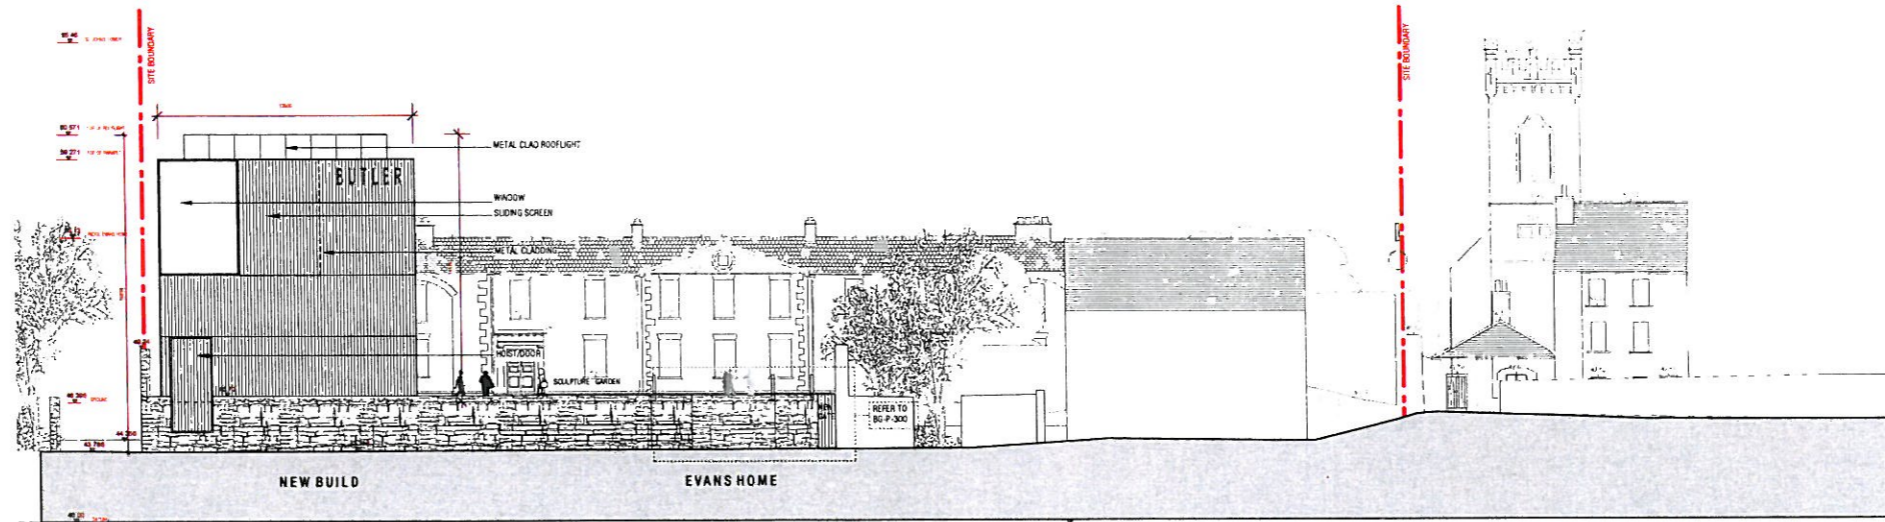

SOUTH WEST ELEVATION

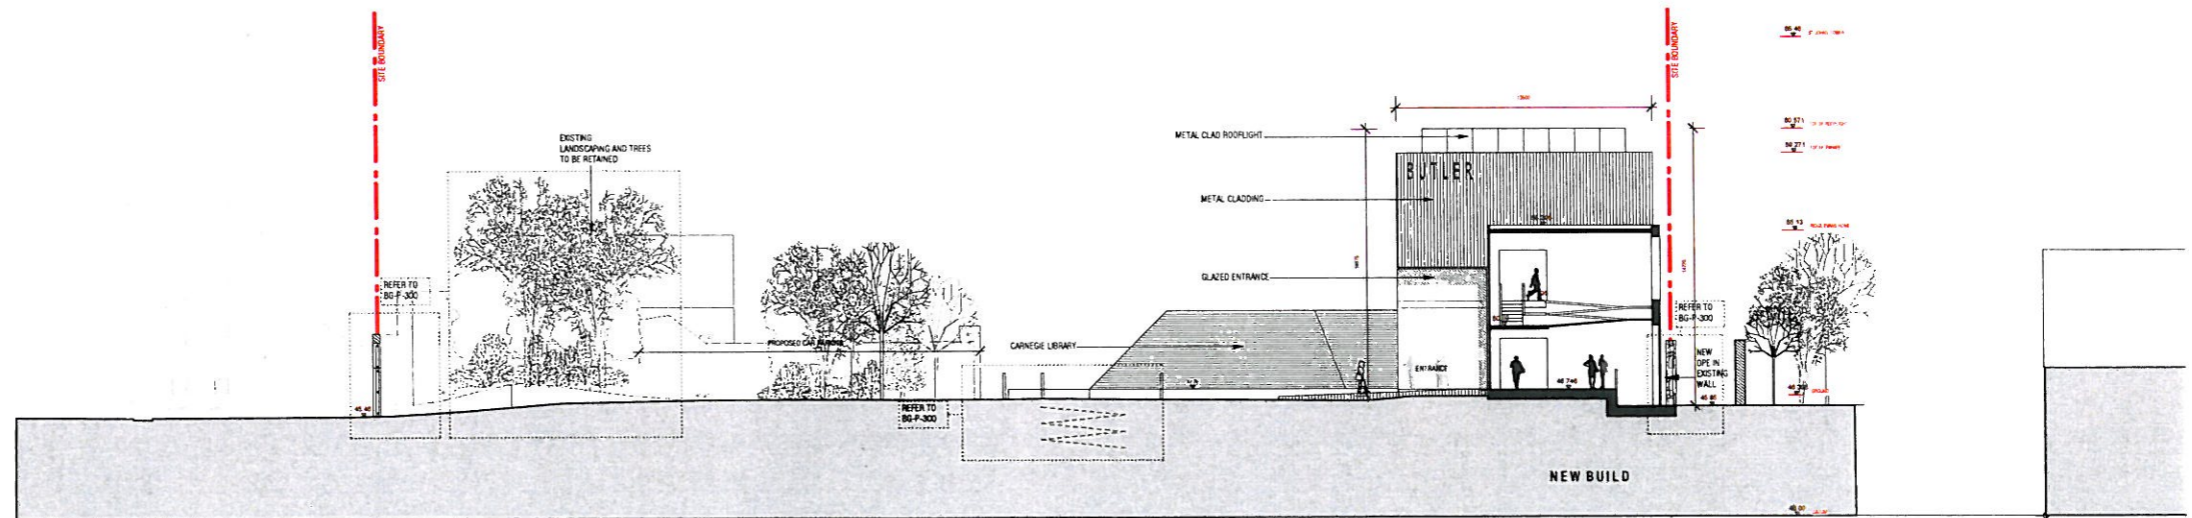


SECTION THROUGH GLAZED LINK AND NORTH EAST ELEVATION

mcculloughmulvinarchitects 1 setanta place, dublin 2, ireland t: +353 1 707 9555 www.mcculloughmulvin.com f: +353 1 707 1912 info@mcculloughmulvin.com	<small> *COPYRIGHT AND OWNERSHIP OF THIS DRAWING IS VESTED IN MCCULLOUGH MULVIN WHOSE PRIOR WRITTEN CONSENT IS REQUIRED FOR ITS USE, REPRODUCTION OR FOR PUBLICATION TO ANY THIRD PARTY. ALL RIGHTS RESERVED BY THE LAW OF COPYRIGHT AND BY INTERNATIONAL COPYRIGHT CONVENTIONS ARE RESERVED TO MCCULLOUGH MULVIN AND MAY BE PROTECTED BY COURT PROCEEDINGS FOR DAMAGES AND/OR INJUNCTIONS AND COSTS. DO NOT SCALE THIS DRAWING. ALL WRITTEN DIMENSIONS ARE IN MILLIMETRES. ANY INCONSISTENCIES TO BE REPORTED TO THE ARCHITECT IMMEDIATELY. © MCCULLOUGH MULVIN 1999 </small>	<table border="1"> <tr> <th>REV</th> <th>DATE</th> <th>BY</th> <th>DESCRIPTION</th> </tr> <tr> <td>B</td> <td>160710</td> <td>roc</td> <td>General drawing update</td> </tr> <tr> <td>D</td> <td>050810</td> <td>LMD</td> <td>GENERAL UPDATE</td> </tr> <tr> <td>E</td> <td>120910</td> <td>LMD</td> <td>GENERAL DRAWING UPDATE</td> </tr> </table>	REV	DATE	BY	DESCRIPTION	B	160710	roc	General drawing update	D	050810	LMD	GENERAL UPDATE	E	120910	LMD	GENERAL DRAWING UPDATE	<table border="1"> <tr> <td>DRAWN</td> <td>LMD</td> <td>PROJECT</td> <td>BUTLER GALLERY</td> <td>SCALE</td> <td>1:200 @A1 1:400@A3</td> <td>DRAWING NUMBER</td> <td></td> </tr> <tr> <td>CHECKED</td> <td>ROH</td> <td>CLIENT</td> <td>KUKENNY ARTS</td> <td>JOB NUMBER</td> <td>201002</td> <td rowspan="2"> <h1>BG-P-161</h1> </td> <td rowspan="2">F</td> </tr> <tr> <td colspan="2">DRAWING TITLE</td> <td colspan="4">Proposed New Build South West & North East Elevation</td> </tr> </table>	DRAWN	LMD	PROJECT	BUTLER GALLERY	SCALE	1:200 @A1 1:400@A3	DRAWING NUMBER		CHECKED	ROH	CLIENT	KUKENNY ARTS	JOB NUMBER	201002	<h1>BG-P-161</h1>	F	DRAWING TITLE		Proposed New Build South West & North East Elevation			
			REV	DATE	BY	DESCRIPTION																																			
B	160710	roc	General drawing update																																						
D	050810	LMD	GENERAL UPDATE																																						
E	120910	LMD	GENERAL DRAWING UPDATE																																						
DRAWN	LMD	PROJECT	BUTLER GALLERY	SCALE	1:200 @A1 1:400@A3	DRAWING NUMBER																																			
CHECKED	ROH	CLIENT	KUKENNY ARTS	JOB NUMBER	201002	<h1>BG-P-161</h1>	F																																		
DRAWING TITLE		Proposed New Build South West & North East Elevation																																							


PROPOSED ALTERATIONS



RIGHT ELEVATION

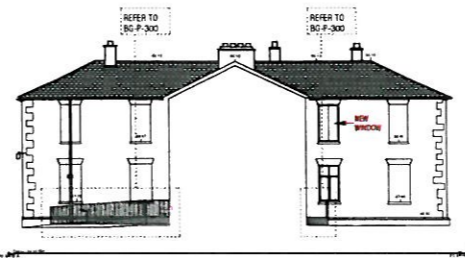

RETURN A ELEVATION

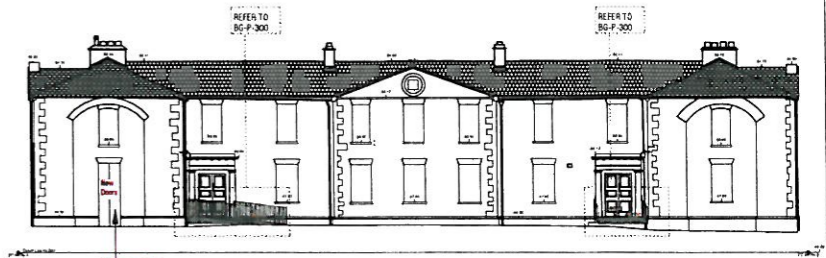


DOORS TO BE FORMED IN EXISTING WINDOW OPE


FRONT ELEVATION



LEFT ELEVATION

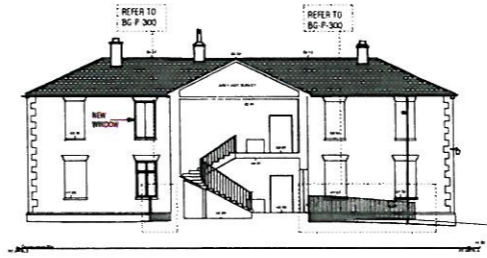


RETURN B ELEVATION

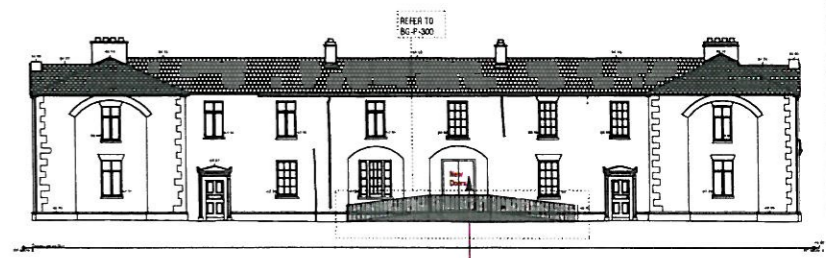

DOOR TO BE FORMED IN EXISTING WINDOW OPE

REAR ELEVATION


DEMOLITIONS

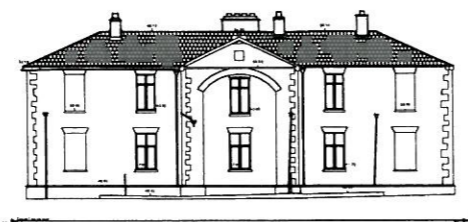


RIGHT ELEVATION



RETURN A ELEVATION

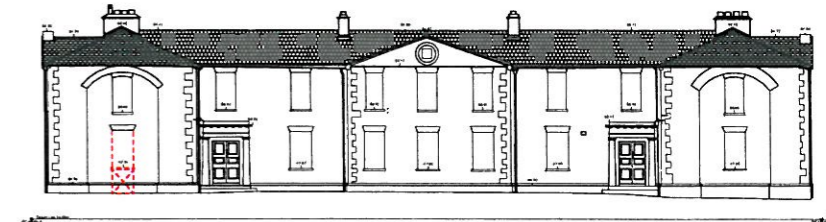


FRONT ELEVATION

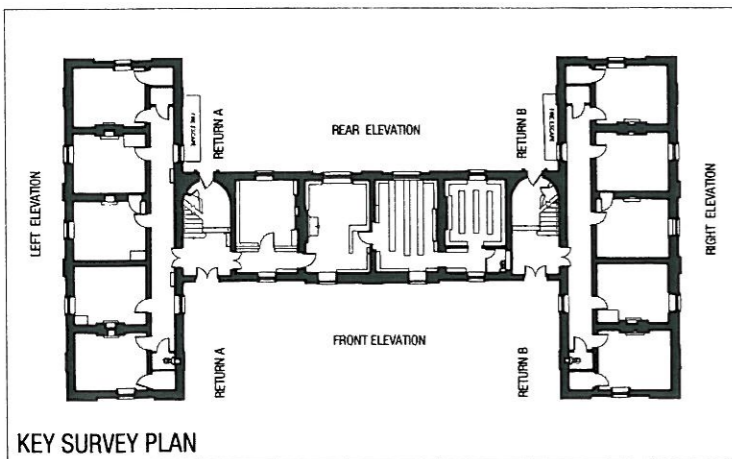


KEY SURVEY PLAN



LEFT ELEVATION

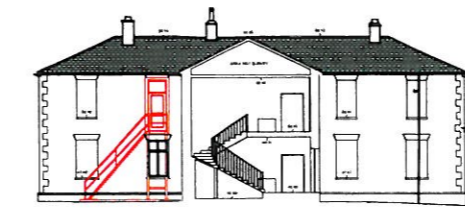

RETURN B ELEVATION

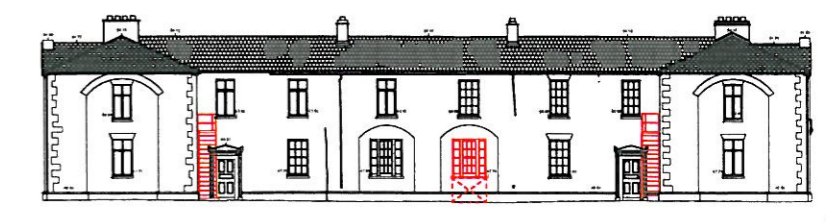

REAR ELEVATION

mcculloughmulvinarchitects
 1 setania place, dublin 2, ireland
 t: +353 1 707 9555 www.mcculloughmulvin.com
 f: +353 1 707 1912 info@mcculloughmulvin.com

*COPYRIGHT AND OWNERSHIP OF THIS DRAWING IS VESTED IN MCCULLOUGH MULVIN WHOSE PRIOR WRITTEN CONSENT IS REQUIRED FOR ITS USE, REPRODUCTION OR FOR PUBLICATION TO ANY THIRD PARTY. ALL RIGHTS RESERVED BY THE LAW OF COPYRIGHT AND BY INTERNATIONAL COPYRIGHT CONVENTIONS ARE RESERVED TO MCCULLOUGH MULVIN AND MAY BE PROTECTED BY COURT PROCEEDINGS FOR DAMAGES AND/OR INJUNCTIONS AND COSTS.
 DO NOT SCALE THIS DRAWING. ALL WRITTEN DIMENSIONS ARE IN MILLIMETRES. ANY INCONSISTENCIES TO BE REPORTED TO THE ARCHITECT IMMEDIATELY.
 © MCCULLOUGH MULVIN 1998


REFER TO
 BG-D-001 SITE, GROUND, FIRST & ROOF DEMOLITIONS
 BG-S-200 SERIES FOR SURVEY PHOTOS
 DATUM SURVEY DRAWINGS FOR SURVEY ELEVATIONS

KEY
 DEMOLITIONS
 NOTE: ALL ELEVATIONS OF EVANS HOME TO BE RENDERED


REV DATE BY DESCRIPTION

DRAWN LMD	PROJECT BUTLER GALLERY	SCALE 1:200 @A1 1:400 @A3	DRAWING NUMBER
CHECKED RCH	CLIENT KILKENNY ARTS	JOB NUMBER 201002	BG-P-164
DRAWING TITLE	EVANS HOME ALTERATION WORKS TO EXISTING ELEVATIONS		

REVISION
 A

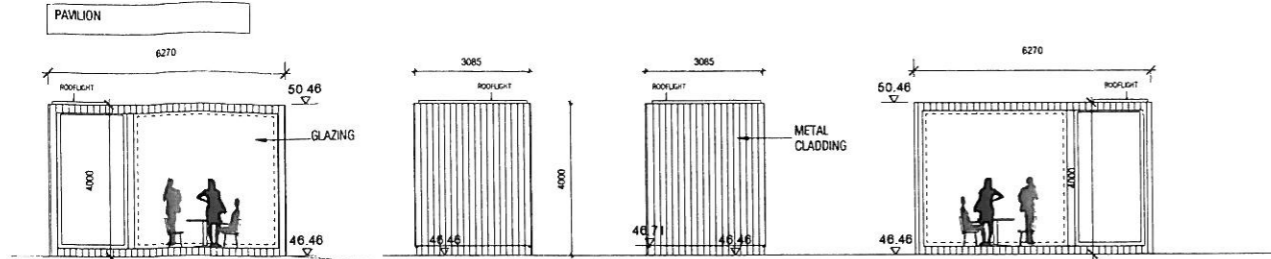


ELEVATION

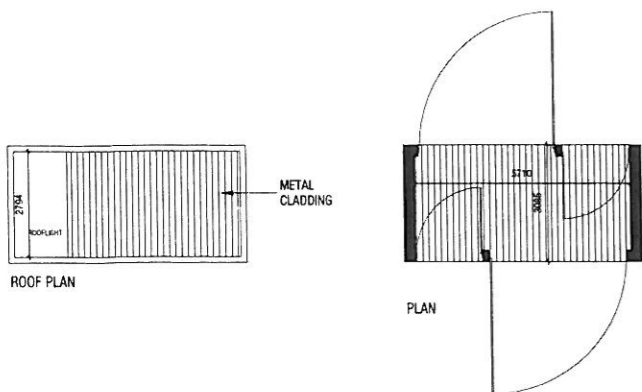


ROOF PLAN

PLAN

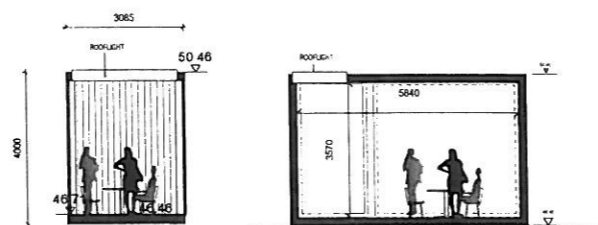


CROSS SECTION

NEW ACCESS GATE IN EXISTING ARCH

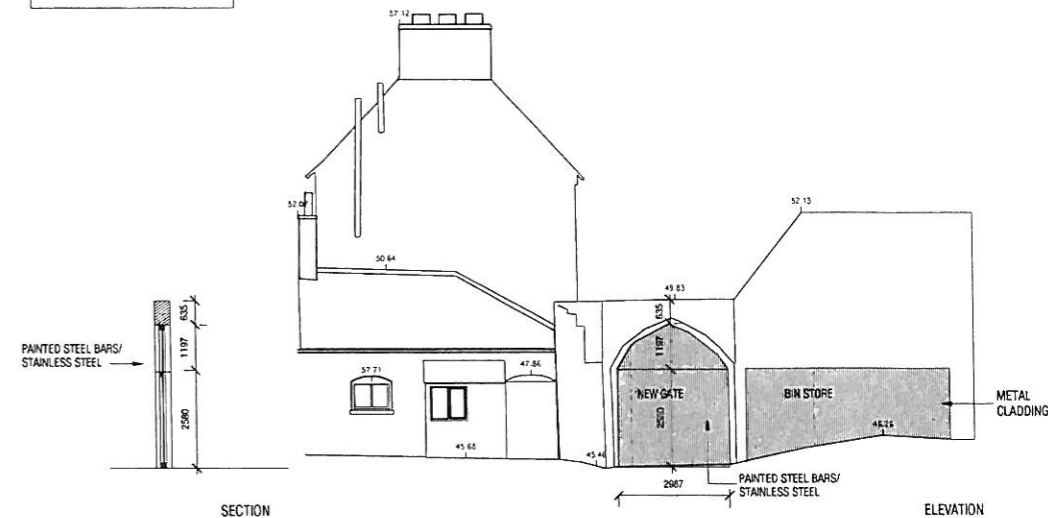

SECTION

ELEVATION

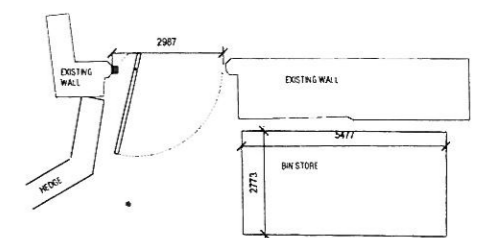


PLAN

ACCESS RAMPS FRONT ELEVATION



ELEVATION


ELEVATION

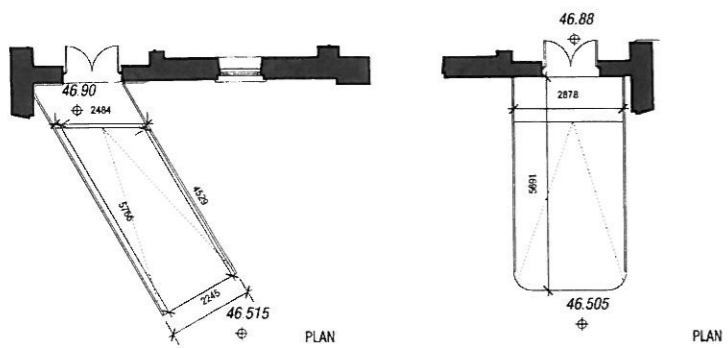


PLAN

PLAN

ACCESS RAMPS REAR ELEVATION

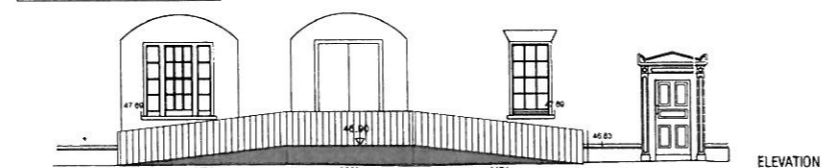


ELEVATION

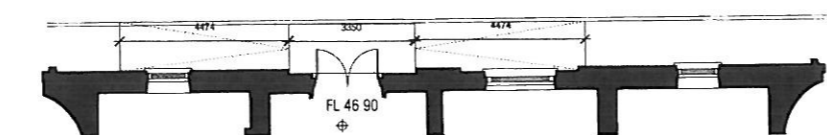


PLAN

PROPOSED NEW RAMP TO PROVIDE ACCESS TO CARNEGIE LIBRARY CAR PARK

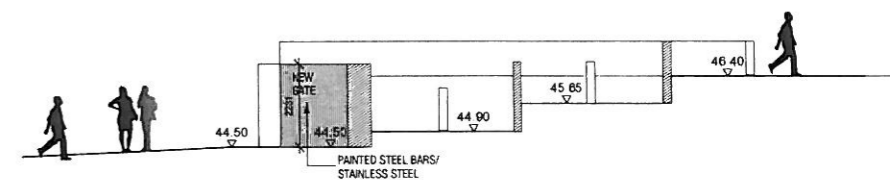


SECTION AA


NEW OPE IN BOUNDARY WALL

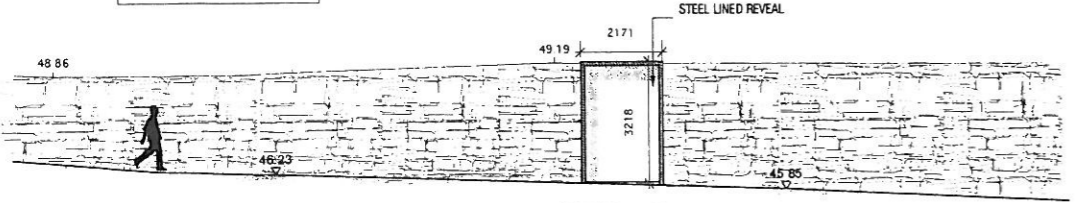

ELEVATION

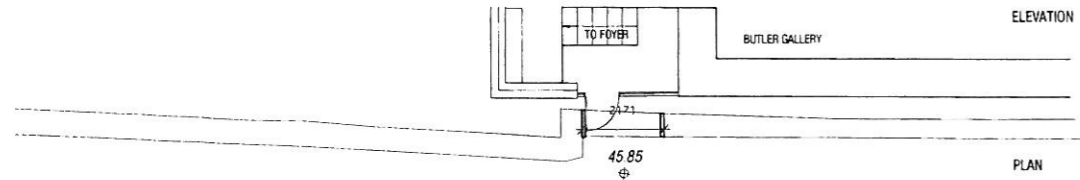

PLAN

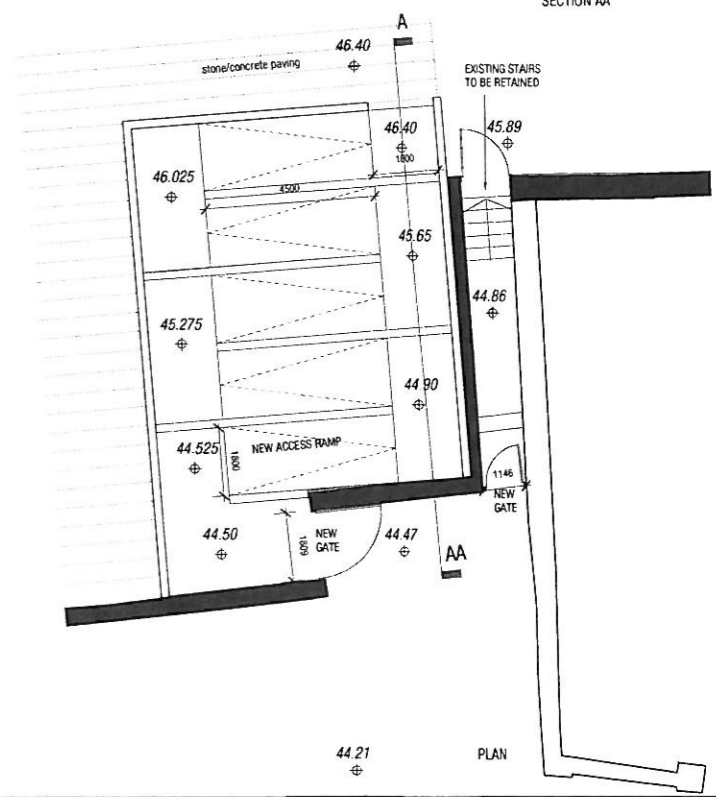

PLAN

mcculloughmulvinarchitects
 1 searson place, dublin 2, ireland
 t: +353 1 707 9553 www.mcculloughmulvin.com
 f: +353 1 707 1812 info@mcculloughmulvin.com

© COPYRIGHT AND OWNERSHIP OF THIS DRAWING IS VESTED IN MCCULLOUGH MULVIN WHOSE PRIOR WRITTEN CONSENT IS REQUIRED FOR ITS USE. REPRODUCTION OR FOR PUBLICATION TO ANY THIRD PARTY.
 ALL RIGHTS RESERVED BY THE LAW OF COPYRIGHT AND BY INTERNATIONAL COPYRIGHT CONVENTIONS ARE RESERVED TO MCCULLOUGH MULVIN AND MAY BE PROTECTED BY COURT PROCEEDINGS FOR DAMAGES AND/OR INJUNCTION AND COSTS.
 DO NOT SCALE THIS DRAWING.
 ALL WRITTEN DIMENSIONS ARE IN MILLIMETRES.
 ANY INCONSISTENCIES TO BE REPORTED TO THE ARCHITECT IMMEDIATELY.
 © MCCULLOUGH MULVIN 1999

REV	DATE	BY	DESCRIPTION

DRAWN LMD	PROJECT BUTLER GALLERY	SCALE 1:100 (BAT 1:200) (A3)	DRAWING NUMBER
CHECKED ROH	CLIENT KUKENNY ARTS	JOB NUMBER 201002	BG-P-300
DRAWING TITLE	Proposed Works to Garden		

REVISION



<p>mcouloughmivnarchitects</p> <p>100 North Main Street, Suite 200, Boston, MA 02111 617.552.1100 www.mcouloughmivn.com</p>	<p><small>THIS DRAWING IS THE PROPERTY OF MC CULOUGH MIVN ARCHITECTS. IT IS TO BE USED ONLY FOR THE PROJECT AND SITE SPECIFICALLY IDENTIFIED HEREIN. NO PART OF THIS DRAWING IS TO BE REPRODUCED OR TRANSMITTED IN ANY FORM OR BY ANY MEANS, ELECTRONIC OR MECHANICAL, INCLUDING PHOTOCOPYING, RECORDING, OR BY ANY INFORMATION STORAGE AND RETRIEVAL SYSTEM, WITHOUT THE WRITTEN PERMISSION OF MC CULOUGH MIVN ARCHITECTS. ALL RIGHTS RESERVED BY MC CULOUGH MIVN ARCHITECTS. © MC CULOUGH MIVN ARCHITECTS 2011</small></p>	<p>REV. DATE. BY. DESCRIPTION</p>		<p>OWNER: BUTLER HALLWAY CLIENT: FLEMING PARTNERS JOB NUMBER: 2011002 DRAWING TITLE: 3D Visual SHEET 1</p>	<p>SCALE: 1/8" = 1'-0" DRAWING NUMBER: BG-P-900</p>
--	--	-----------------------------------	--	---	---



<p>mceulloughmutvinarchitects</p> <p>1000 Broadway, Suite 200, New York, NY 10003 Tel: +1 212 675 1000 Fax: +1 212 675 1001 www.mceulloughmutvin.com</p>	<p><small>Copyright and ownership of this drawing is held by MCEULLOUGH MUTVIN ARCHITECTS. All rights reserved. No part of this drawing may be reproduced, stored in a retrieval system, or transmitted in any form or by any means, electronic, mechanical, photocopying, recording, or by any information storage and retrieval system, without the prior written permission of MCEULLOUGH MUTVIN ARCHITECTS.</small></p> <p>DO NOT SCALE THIS DRAWING ALL DIMENSIONS SHOWN ARE IN METERS ANY DIMENSIONS TO BE REFERRED TO IN METERS TO THE LARGEST DIMENSION</p>			<p>REV. DATE BY DESCRIPTION</p>	<p>DESIGN: LAD PROJECT: TYLER GALLERY CHECKED: DAVID MURPHY DATE: 201002 DRAWN: 3D Visual SHEET 2</p>	<p>SCALE: 1:1 DRAWING NUMBER: BG-P-901</p>	<p>REVISION</p>
--	--	--	--	---------------------------------	--	--	-----------------